


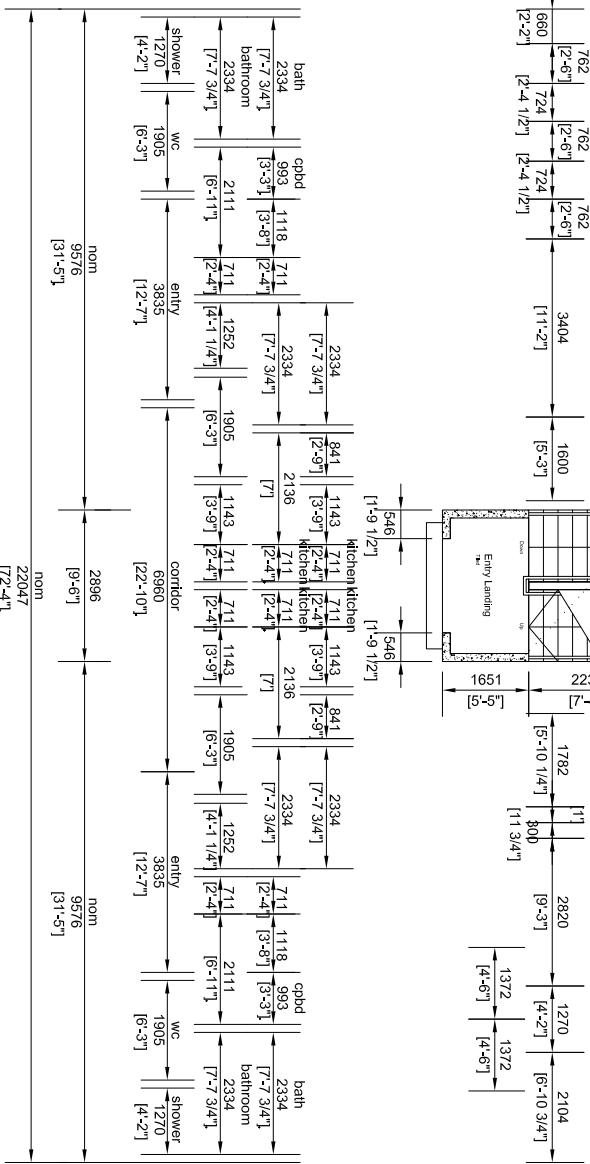
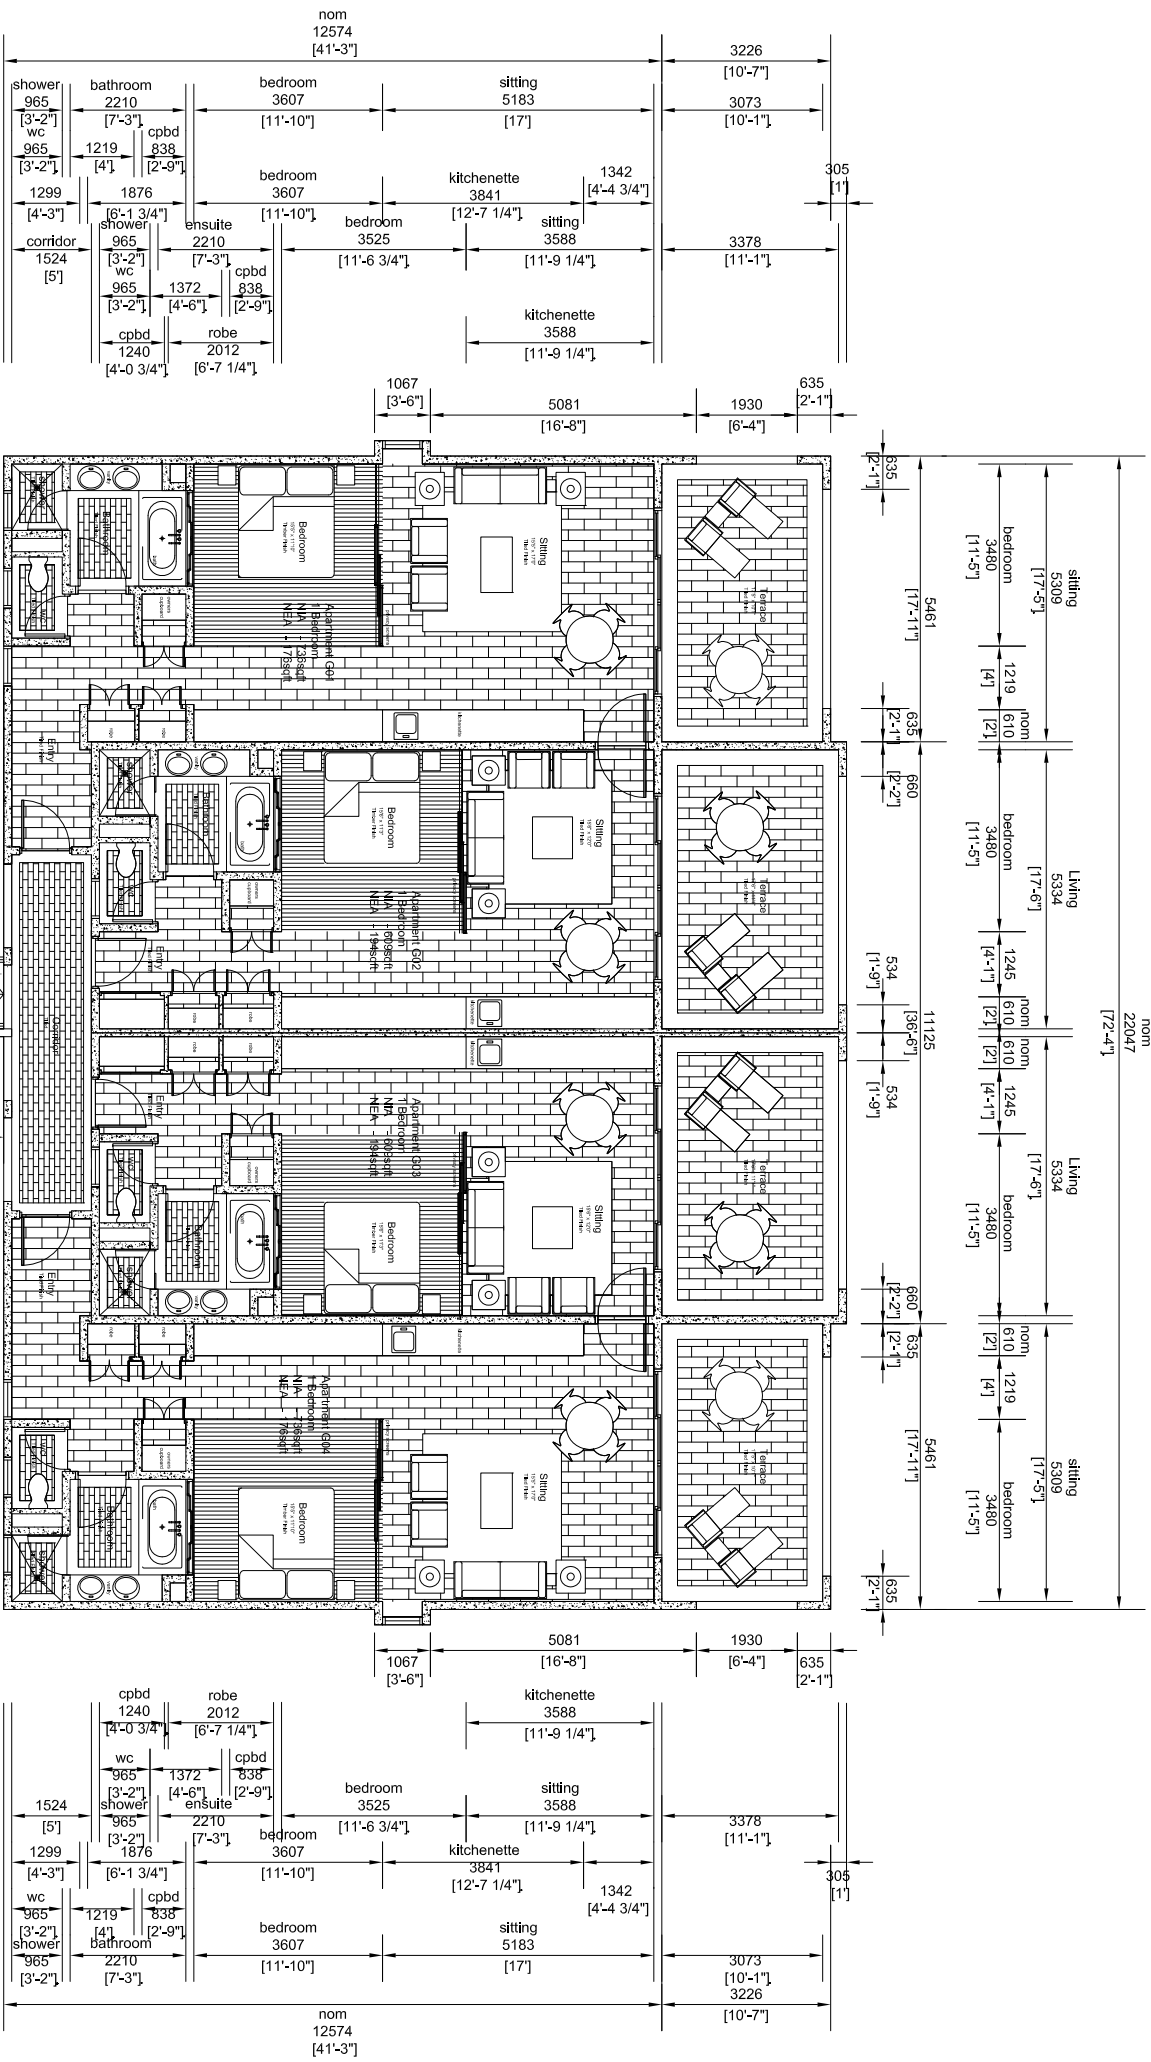
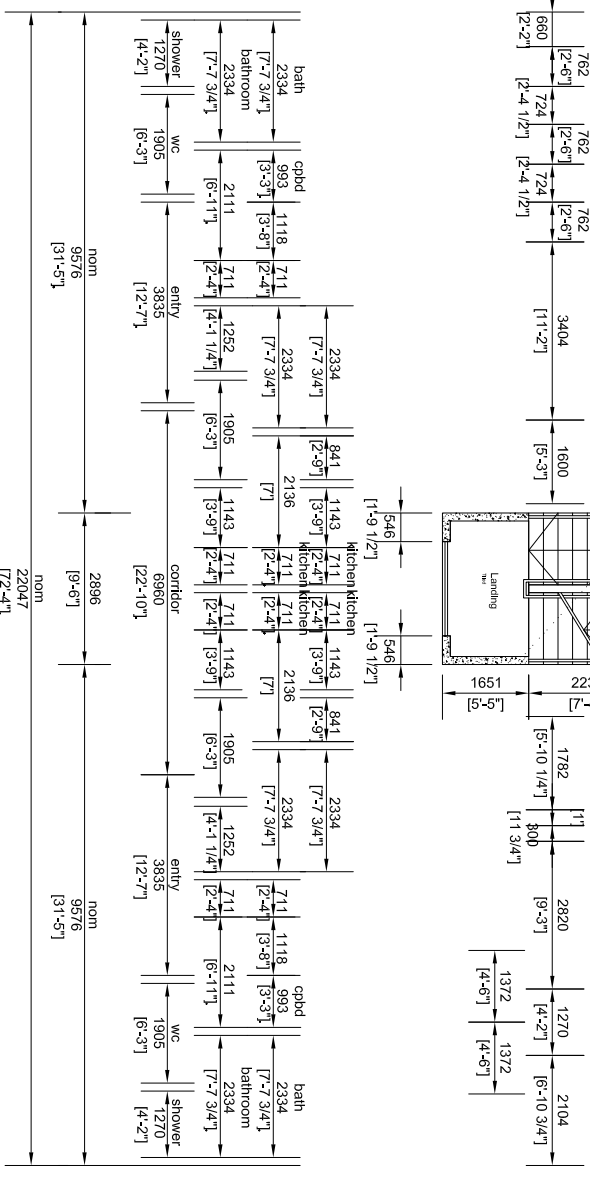
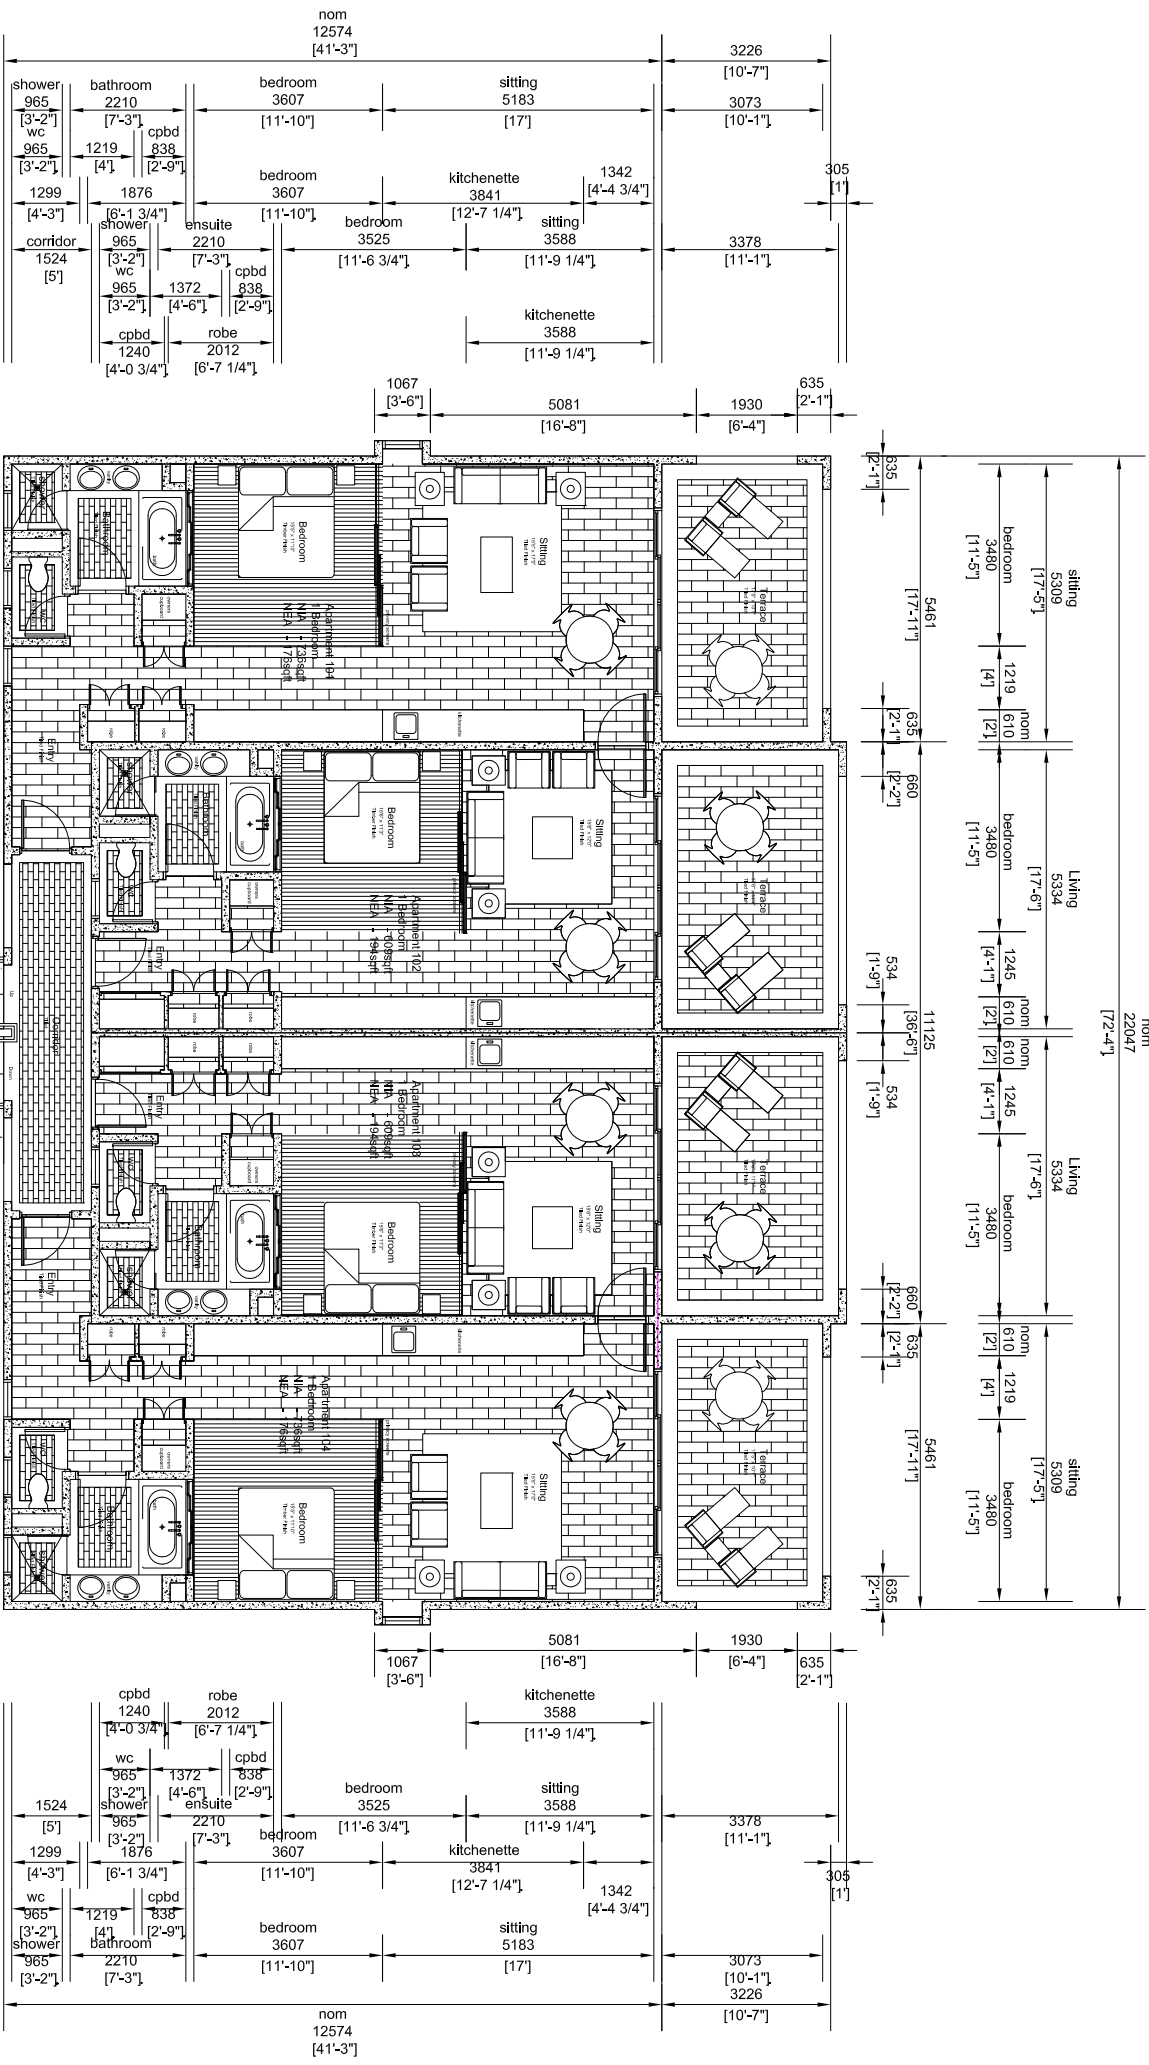
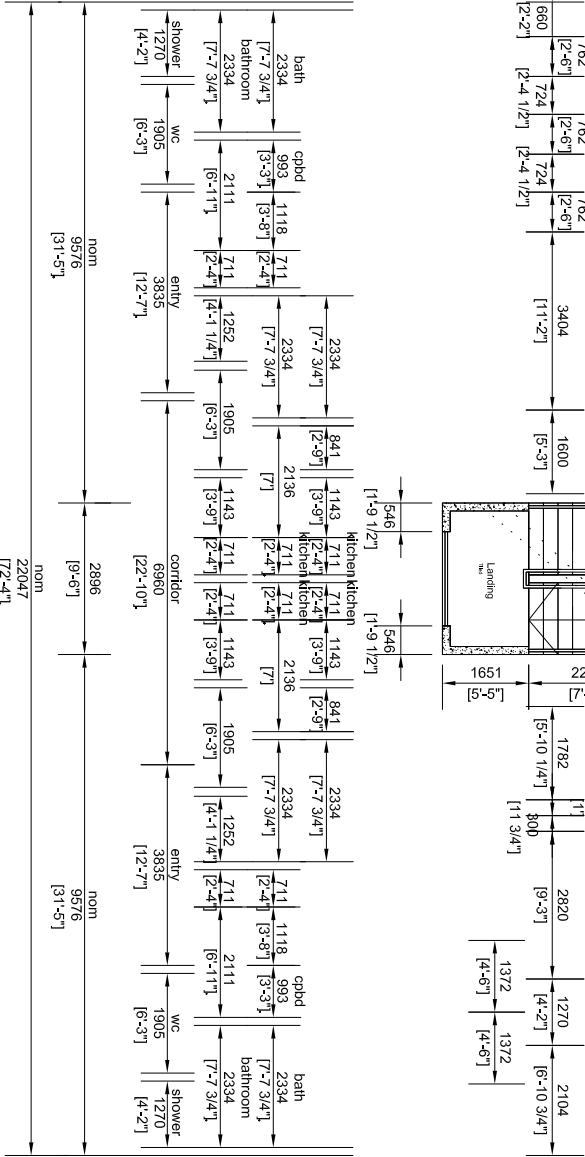


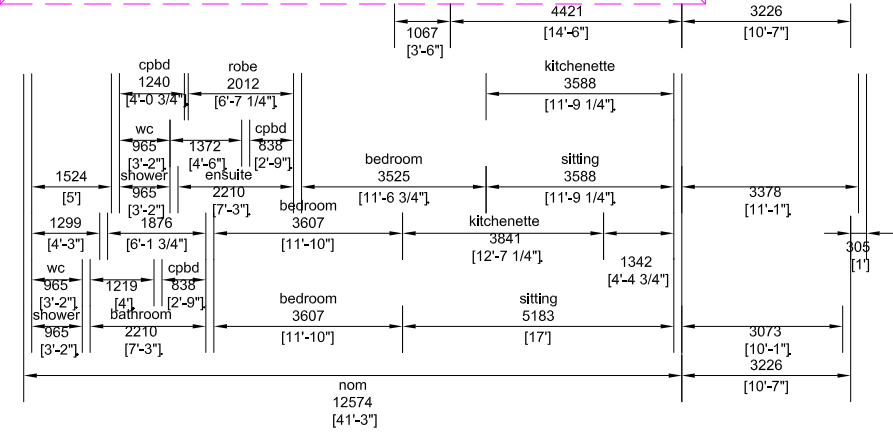


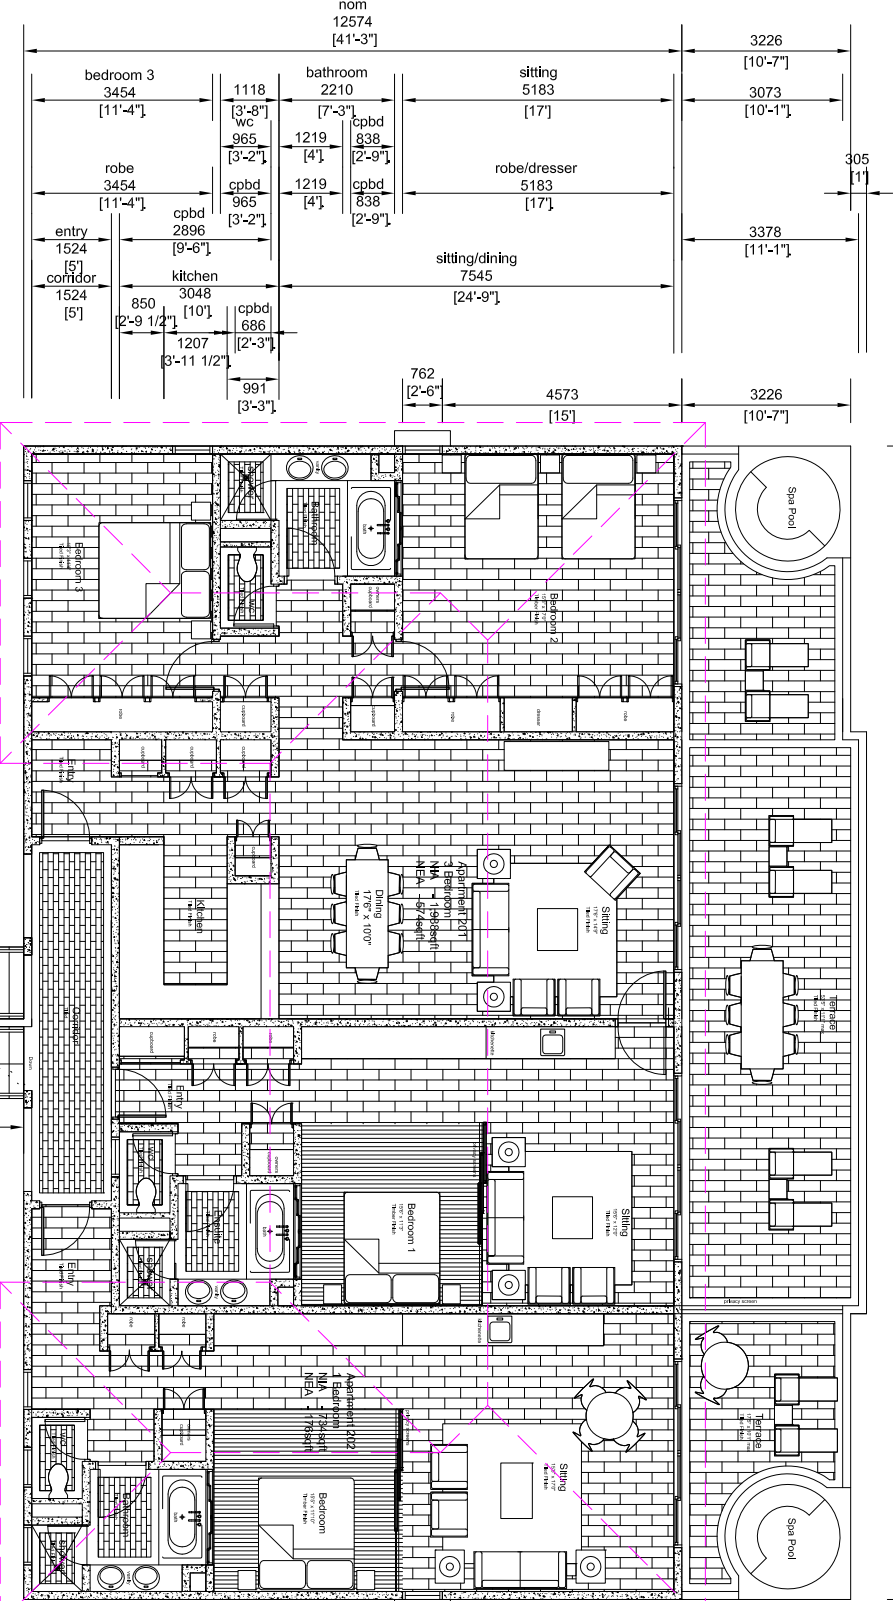


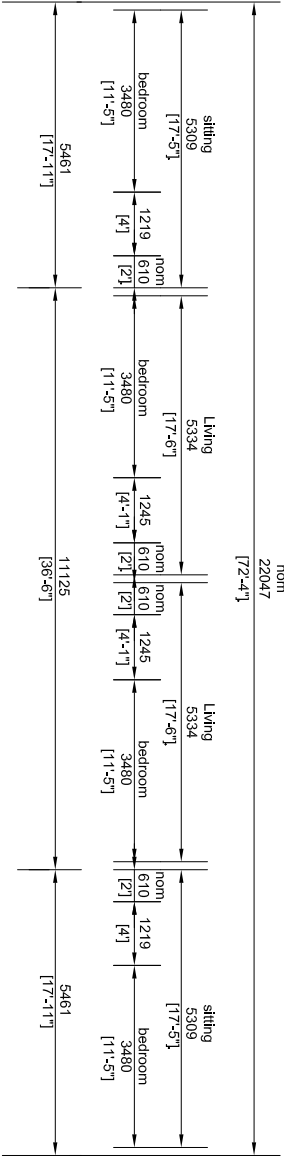

CABLE BAY HOTEL DEVELOPMENT COMPANY LTD

Beachfront Apartment Buildings
BF01 - BF04
Second Floor Plan

Drawing No. BF01/04 - SK - 03

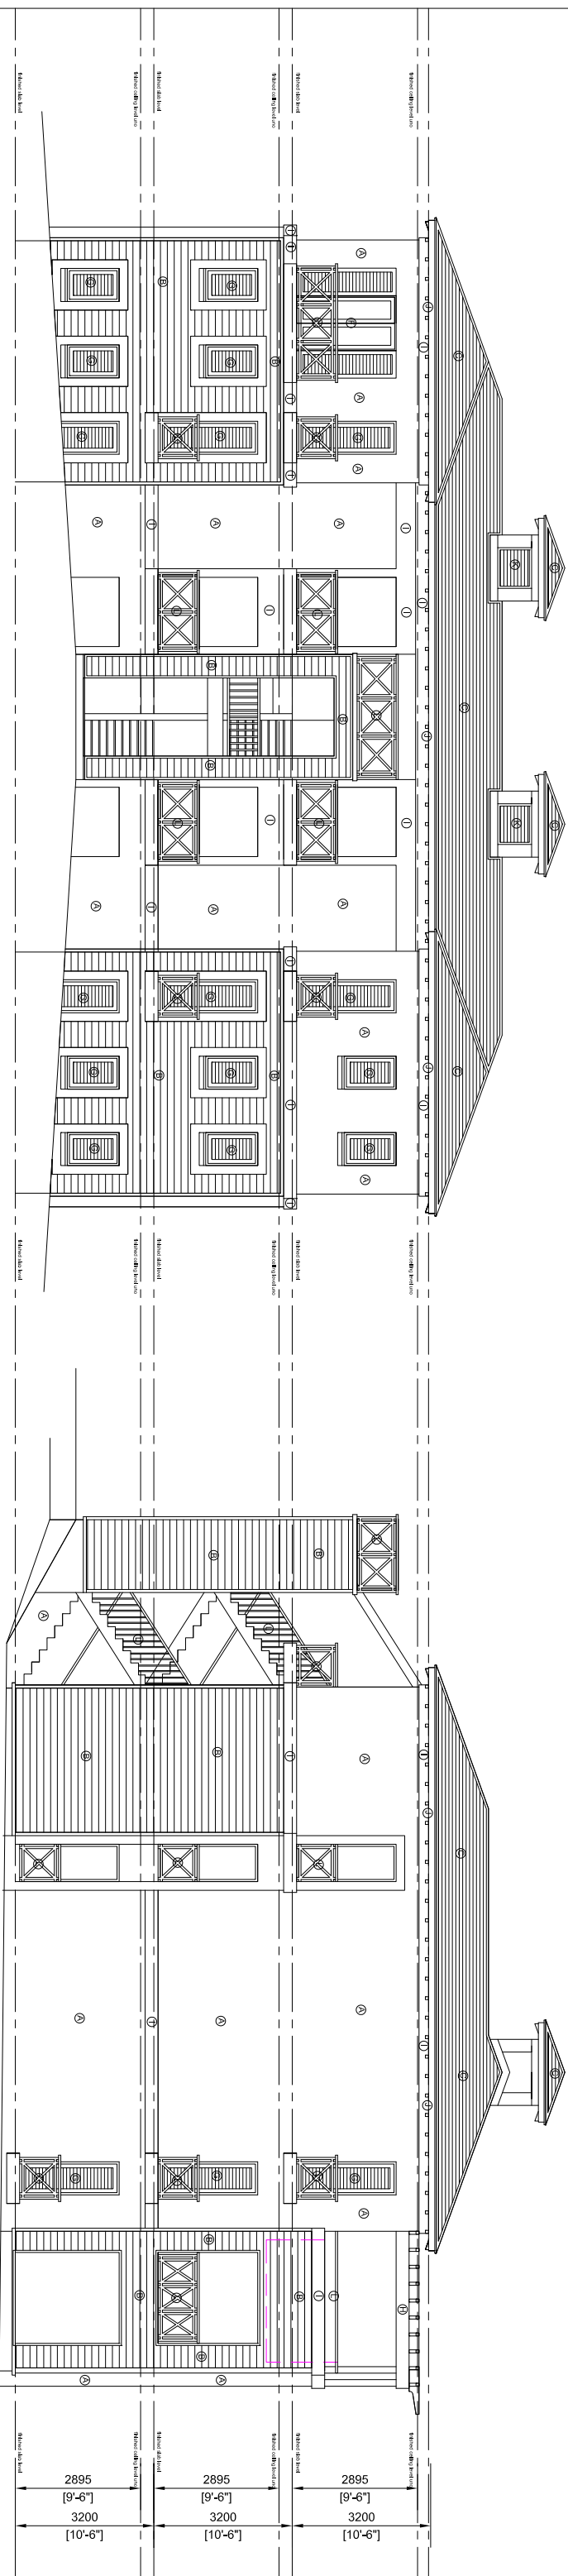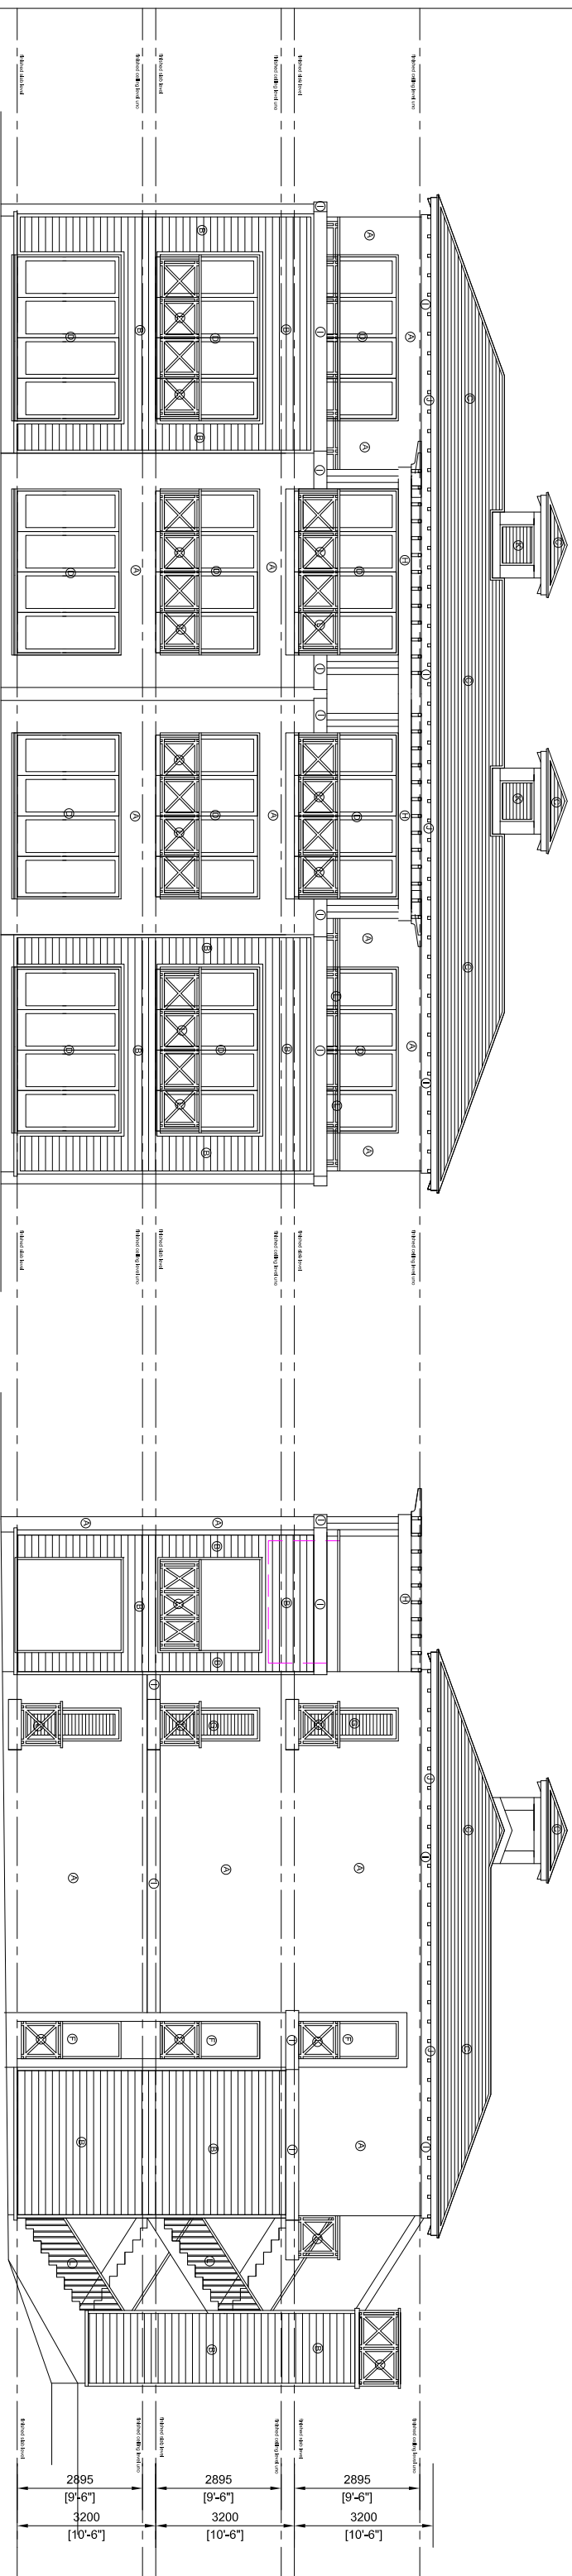


- | FINISHES LEGEND | |
|-----------------|--|
| (A) | Rendered masonry - Paint finish |
| (B) | Composite horizontal cladding - Paint finish |
| (C) | Re-cycled roof tiles |
| (D) | Powercoated aluminium frame/glazed sliding Doors |
| (E) | Powercoated aluminium frame/glazed windows |
| (F) | Powercoated aluminium frame/glazed doors |
| (G) | Timber cladding - Paint finish |
| (H) | Timber framed parapet - Paint finish |
| (I) | 10mm rendered feature band - Paint finish |
| (J) | Exposed timber refer to sawn - Paint finish |
| (K) | Timber roof void - paint finish |
| (L) | Aluminium balustrade - Powdercoat finish |
| (M) | Selected tile to pool face |

OCEAN'S EDGE
ST. KITTS AND NEVIS

CABLE BAY HOTEL DEVELOPMENT COMPANY LTD

Beachfront Apartment Buildings BF01 to BF04 Elevations

Drawing No. BF01/04 - SK - 10

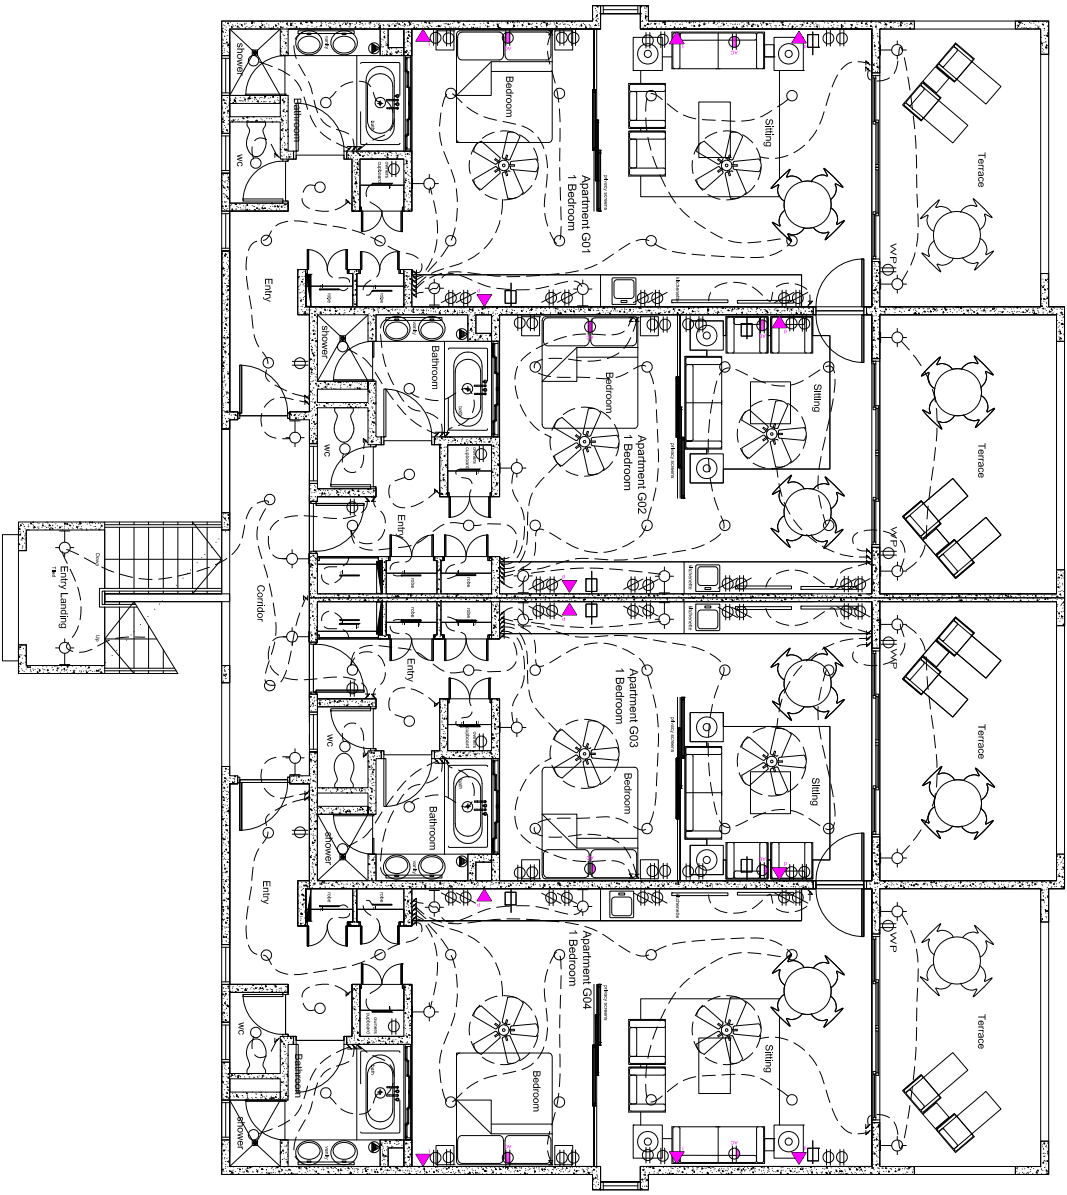

ELECTRICAL LEGEND

⌀ Duplex receptacle outlet 12" AFF 120V

⌘ Duplex receptacle outlet above bench 120V

⌀^{W/P} Waterproof duplex receptacle outlet 12" AFF 120V

● Single shaving receptacle outlet 40A

↘ Single pole switch

≡ Two-way switch

○ Recessed downlight

⌋ Wall mounted incandescent light fixture

— Fluorescent panel lighting

— Mini fluorescent wardrobe light (door switched)

○ Pod light

 
— Electrical Panel

▲ Data outlet

▲ Telephone outlet

⌋ Cable TV outlet


⌋ Wall mounted air conditioning unit power supply



Fan



CABLE BAY HOTEL DEVELOPMENT COMPANY LTD

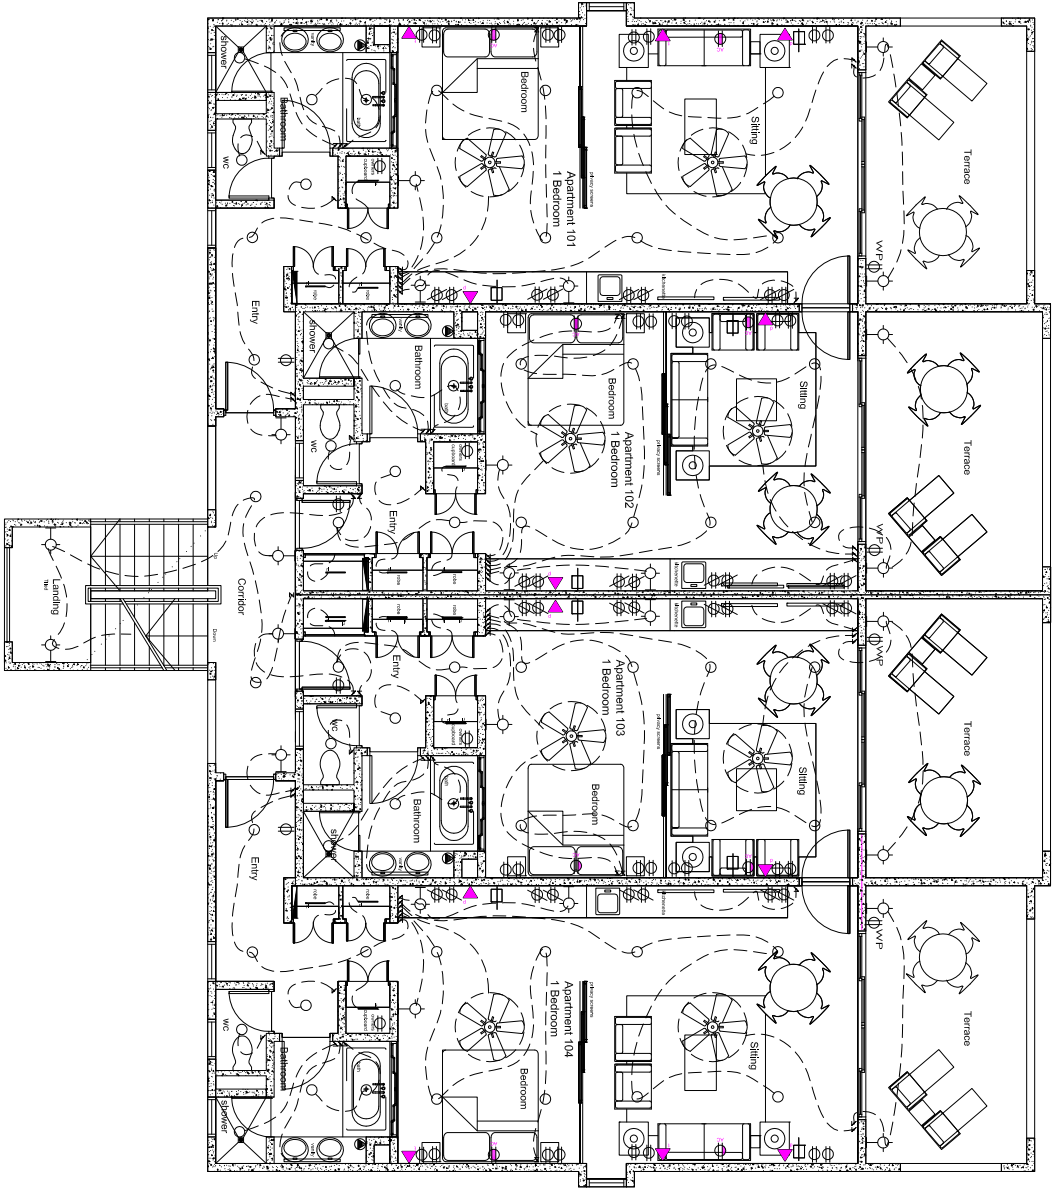

ELECTRICAL LEGEND


- ⌀ Duplex receptacle outlet 12" AFF 120V
- ⌘ Duplex receptacle outlet above bench 120V
- ⌀_{W/P} Waterproof duplex receptacle outlet 12" AFF 120V
- Single shaving receptacle outlet 40A
- ↘ Single pole switch
- ↗ Two-way switch
- Recessed downlight
- ⌒ Wall mounted incandescent light fixture
- Fluorescent palmel lighting
- Mini fluorescent wardrobe light (door switched)
- ◌ Pod light
- ▬ Electrical Panel
- ▼ Data outlet
- ▼ Telephone outlet
- ⌘ Cable TV outlet
- ⌘ Wall mounted air conditioning unit power supply
- ⌘ Fan



CABLE BAY HOTEL DEVELOPMENT COMPANY LTD

Drawing No. BF01/04 - SK - E02

Beachfront Apartment Buildings
BF01 - BF04
Electrical Layout - First Floor Plan

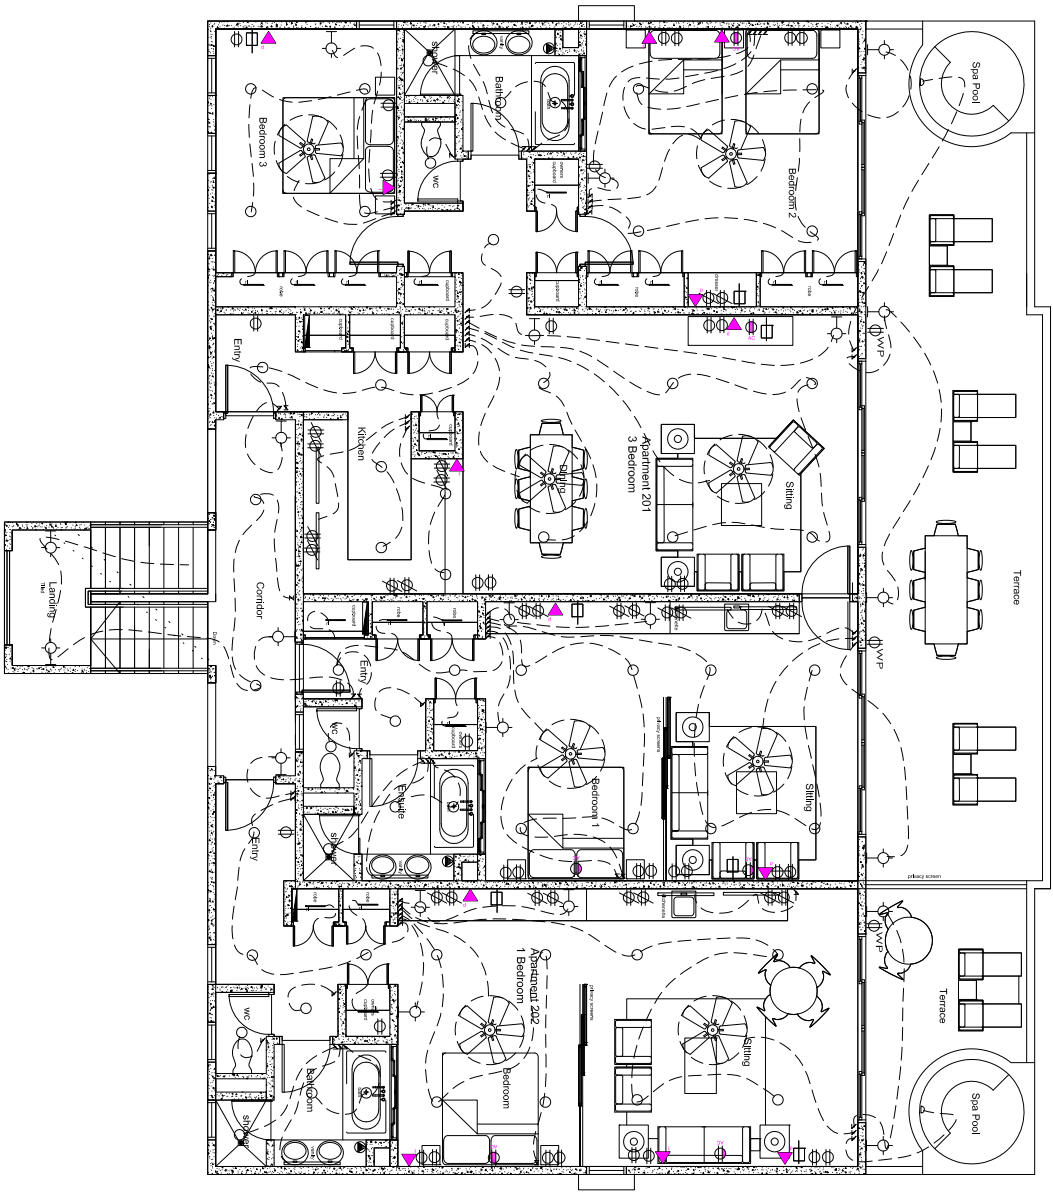

ELECTRICAL LEGEND

- ⌀ Duplex receptacle outlet 12" AFF 120V
- ⌀ Duplex receptacle outlet above bench 120V
- ⌀ Waterproof duplex receptacle outlet 12" AFF 120V
- Single shaving receptacle outlet 40A
- ↘ Single pole switch
- ↗ Two-way switch
- Recessed downlight
- Wall mounted incandescent light fixture
- Fluorescent panel lighting
- Mini fluorescent wardrobe light (door switched)
- Pool light
- Electrical Panel
- ▲ Data outlet
- ▲ Telephone outlet
- ▮ Cable TV outlet
- ⦿ Wall mounted air conditioning unit power supply
- ⊙ Fan



CABLE BAY HOTEL DEVELOPMENT COMPANY LTD

Beachfront Apartment Buildings
BF01 - BF04
Electrical Layout - Second Floor Plan

Drawing No. BF01/04 - SK - E03