
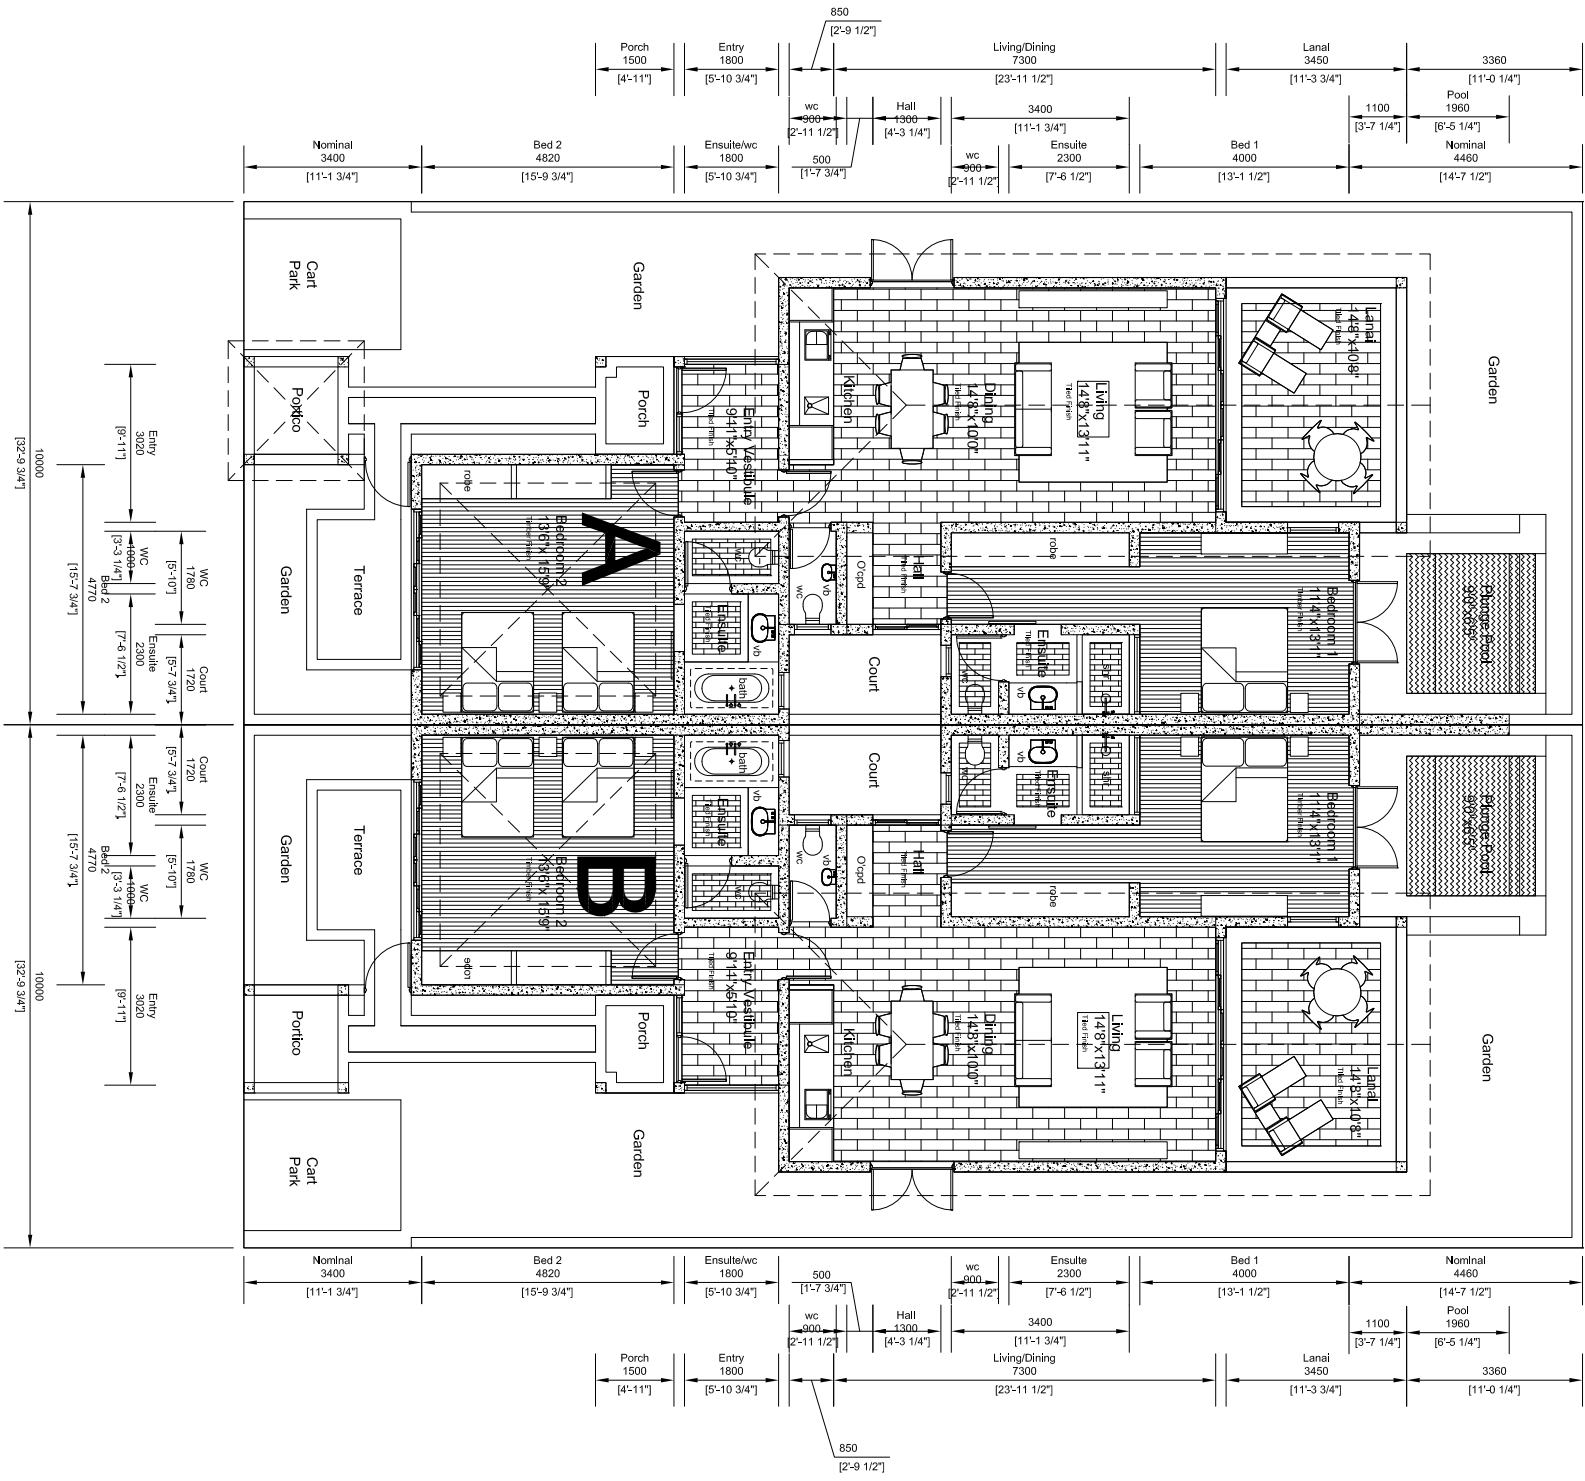


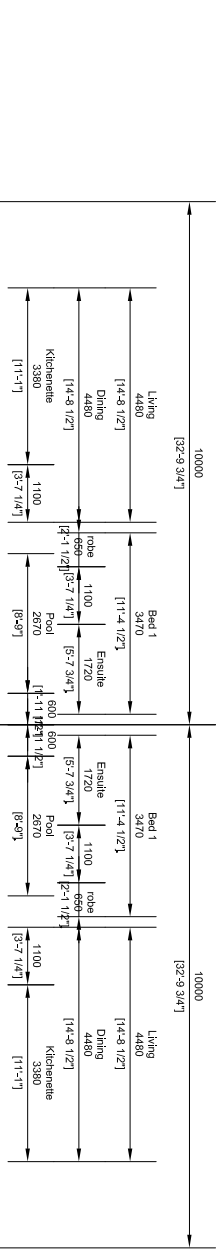


CABLE BAY HOTEL DEVELOPMENT COMPANY LTD

Ground Floor Plan

Poolside Cottages - Type A/B
2 Bedroom Single Storey Duplex

Drawing No. PC/AB - SK - 01

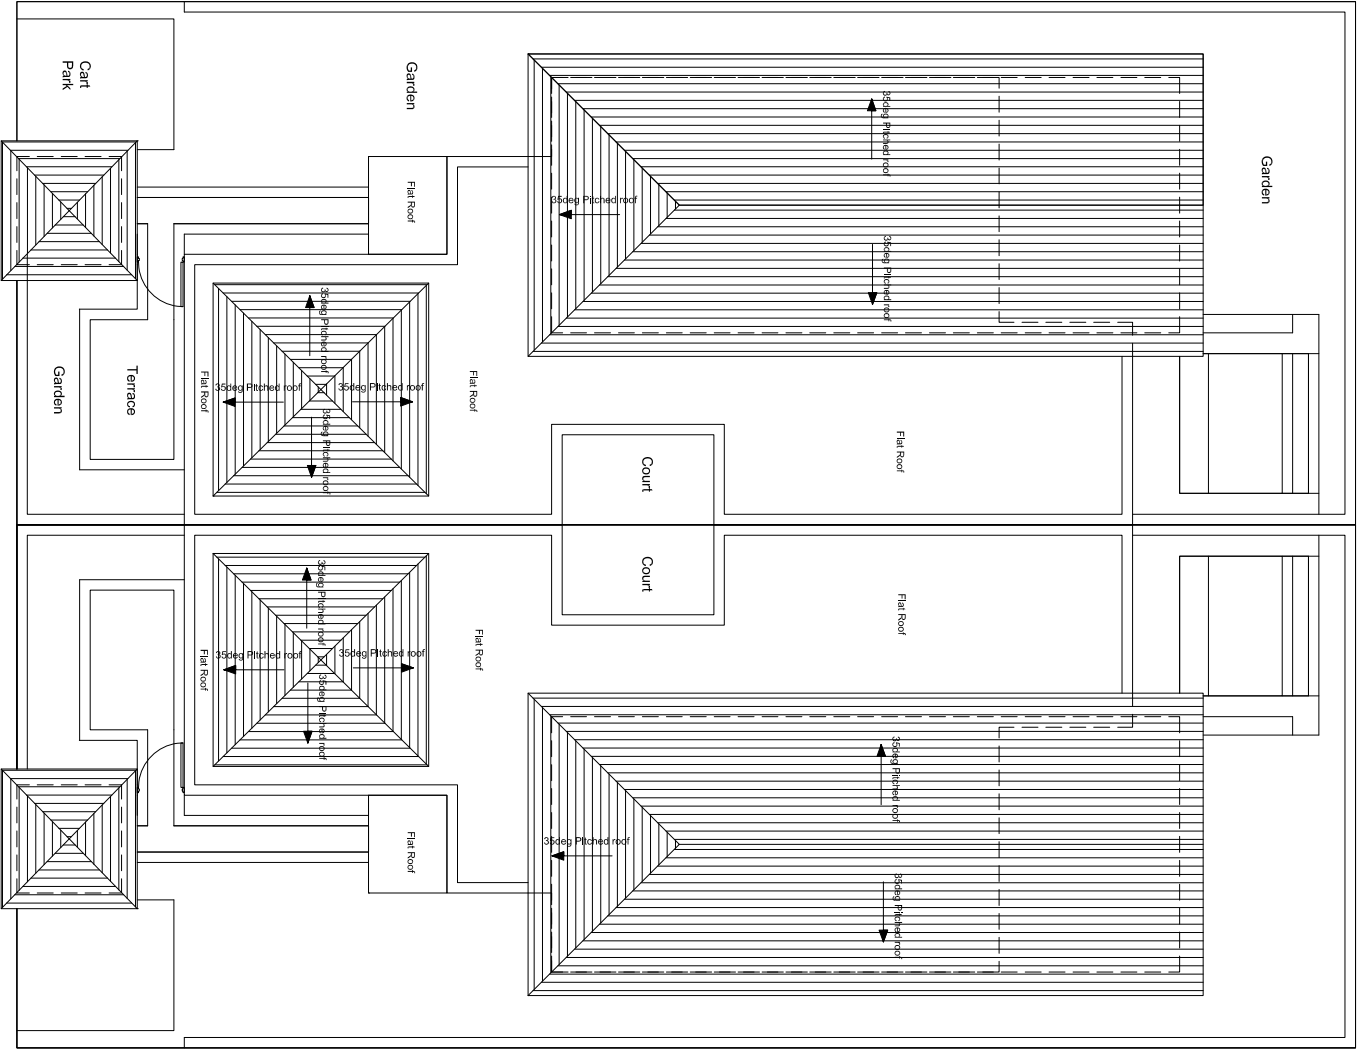

Ground Floor Plan

Poolside Cottages - Type A/B
2 Bedroom Single Storey Duplex





CABLE BAY HOTEL DEVELOPMENT COMPANY LTD

Roof Floor Plan

Poolside Cottages - Type A/B
2 Bedroom Single Storey Duplex

Drawing No. PC/AB - SK - 02

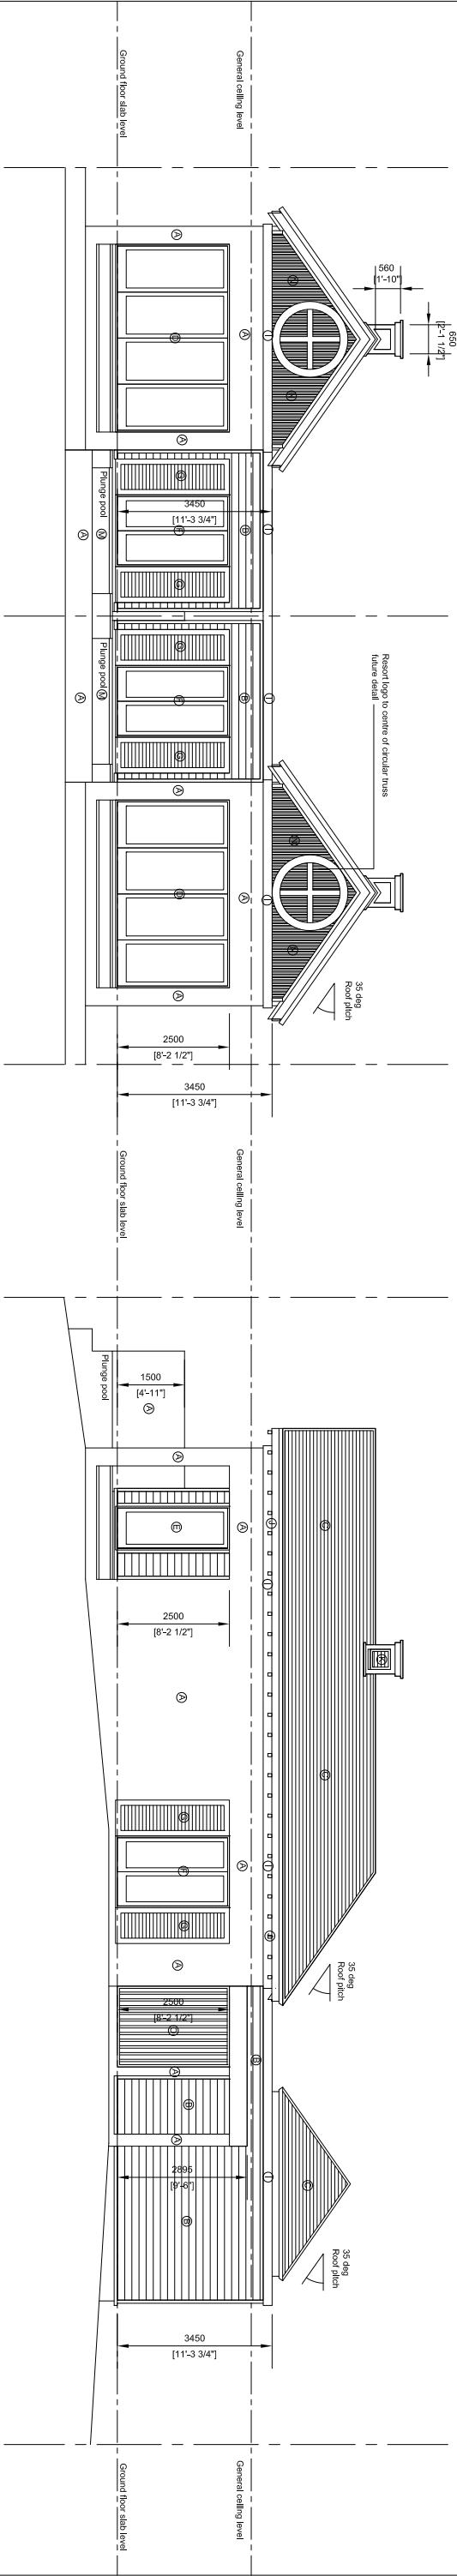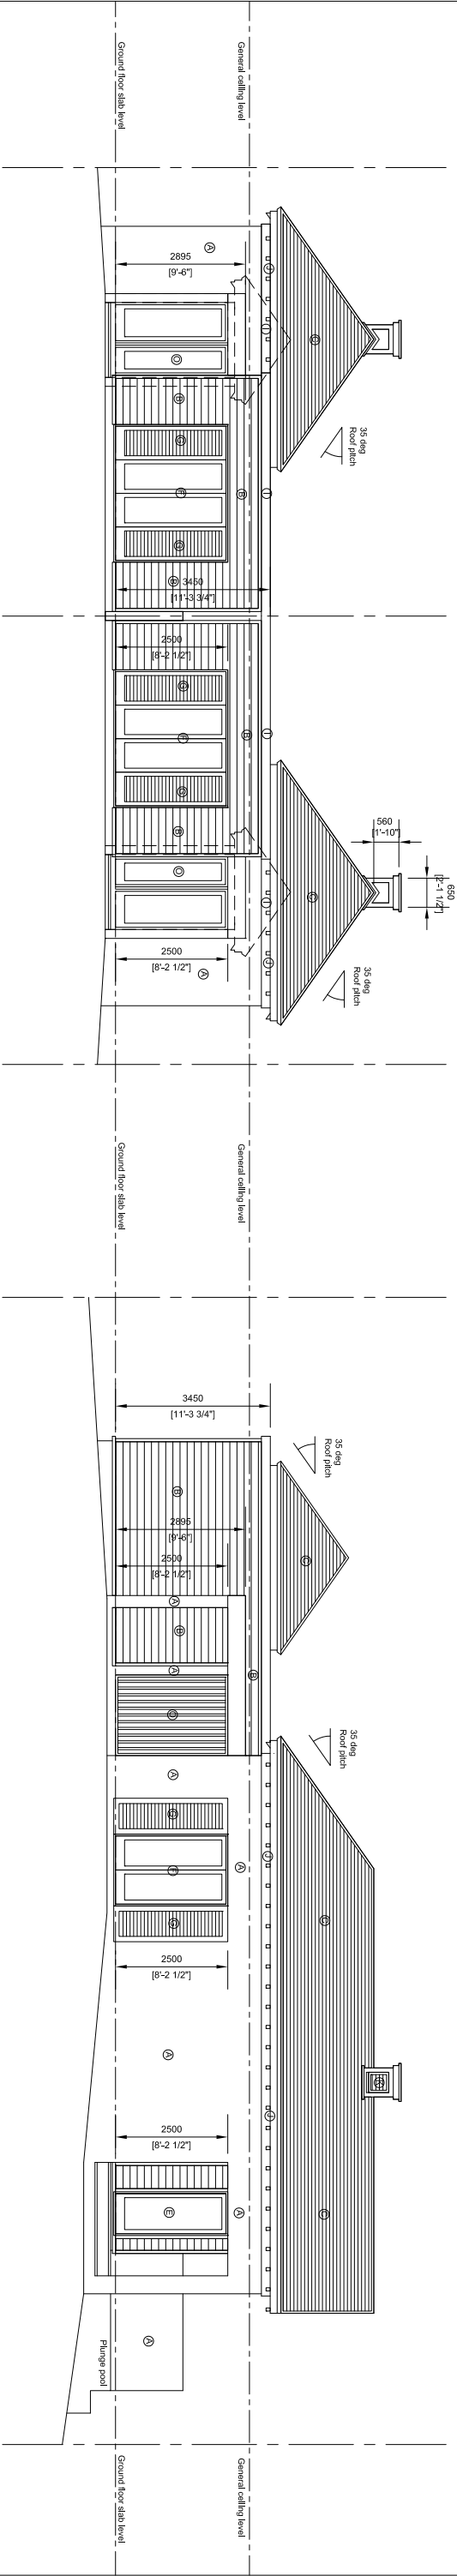

- FINISHES LEGEND
- ① Rendered masonry - Paint finish
 - ② Composite horizontal cladding - Paint finish
 - ③ Re-cycled roof shingles
 - ④ Powdercoated aluminium framed/glassed sliding Doors
 - ⑤ Powdercoated aluminium framed/glassed windows
 - ⑥ Powdercoated aluminium framed/glassed hinged doors
 - ⑦ Timber shutters - Paint finish
 - ⑧ Timber framed pergola - Paint finish
 - ⑨ Tonn rendered feature band - Paint finish
 - ⑩ Exposed timber eaves to eaves - Paint finish
 - ⑪ Timber roof vent - Paint finish
 - ⑫ Aluminium balustrade - Powdercoat finish
 - ⑬ Selected tile to pool base
 - ⑭ Vertical timber battens - Paint finish
 - ⑮ Vertical timber battens - Oil finish
 - P Timber ventilation bricks - Oil finish


OCEAN'S EDGE
ST. KITTS AND NEVIS

CABLE BAY HOTEL DEVELOPMENT COMPANY LTD

Elevations

Poolside Cottages - Type A/B
2 Bedroom Single Storey Duplex

Drawing No. PC/AB - SK - 10

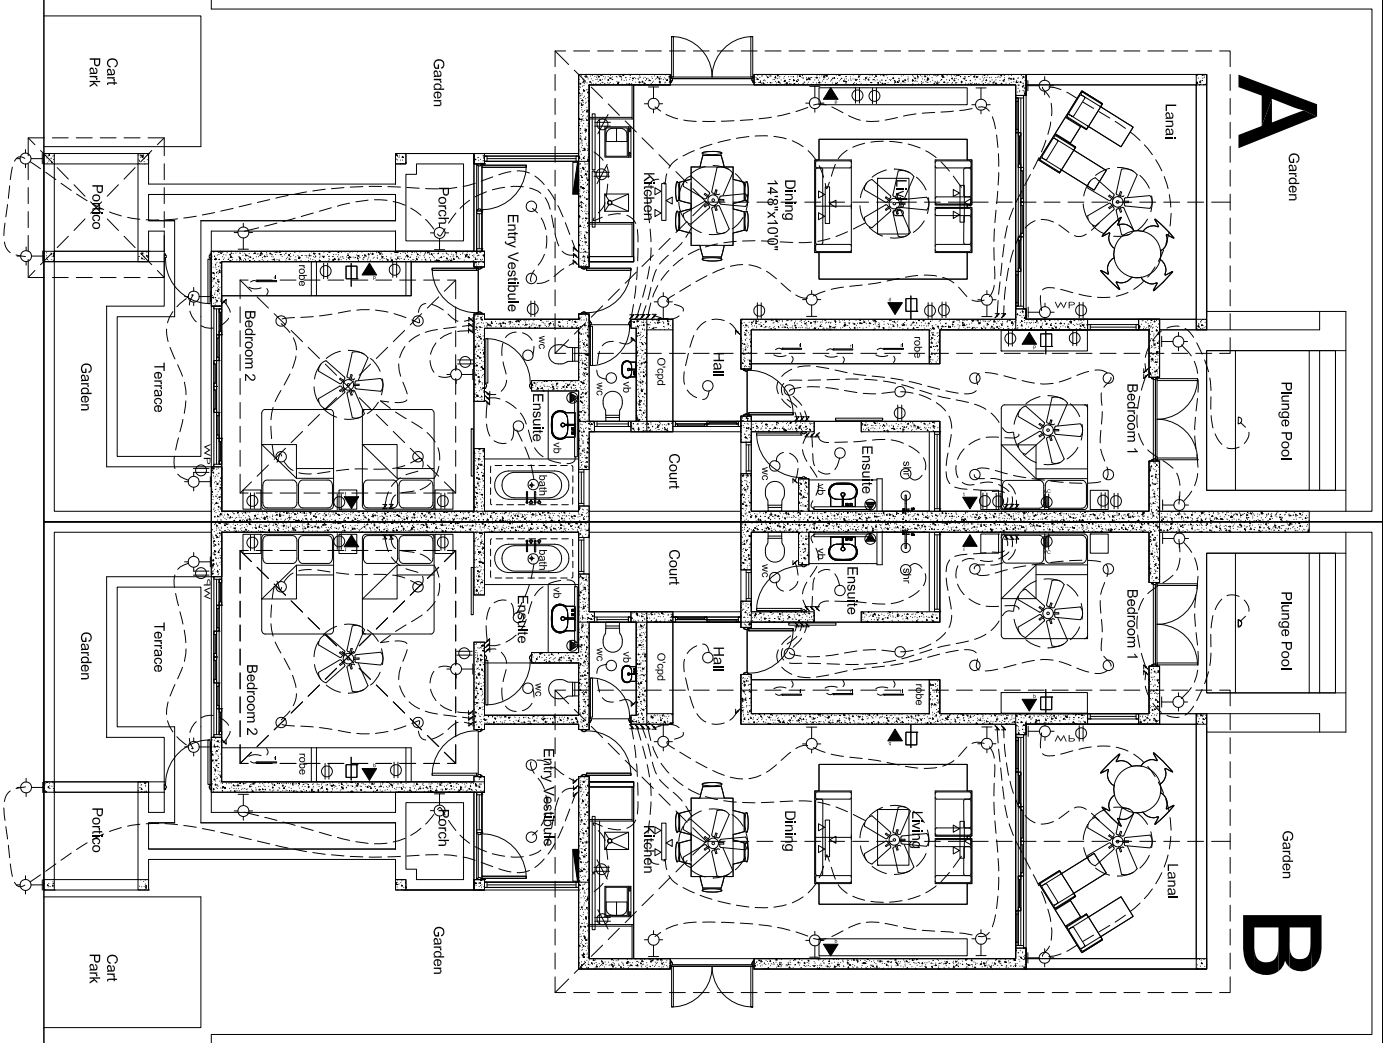

ELECTRICAL LEGEND

⌀ Duplex receptacle outlet 12" AFF 120V

⌘ Duplex receptacle outlet above bench 120V

⌀^{W/P} Waterproof duplex receptacle outlet 12" AFF 120V

● Single shawing receptacle outlet 40A

⋈ Single pole switch

⋈ Two-way switch

○ Recessed downlight

⌒ Wall mounted incandescent light fixture

⌒ Fluorescent pelmet lighting

⌒ Mini fluorescent wardrobe light (door switched)

○ Pod light

⌒ Electrical Panel

▼ Data outlet

▼ Telephone outlet

⌒ Cable TV outlet

⌒ Wall mounted air conditioning unit power supply

Fan



Electrical Layout - Ground Floor Plan

Poolside Cottages - Type A/B

2 Bedroom Single Storey Duplex

Drawing No. PC/AB - SK - E01