



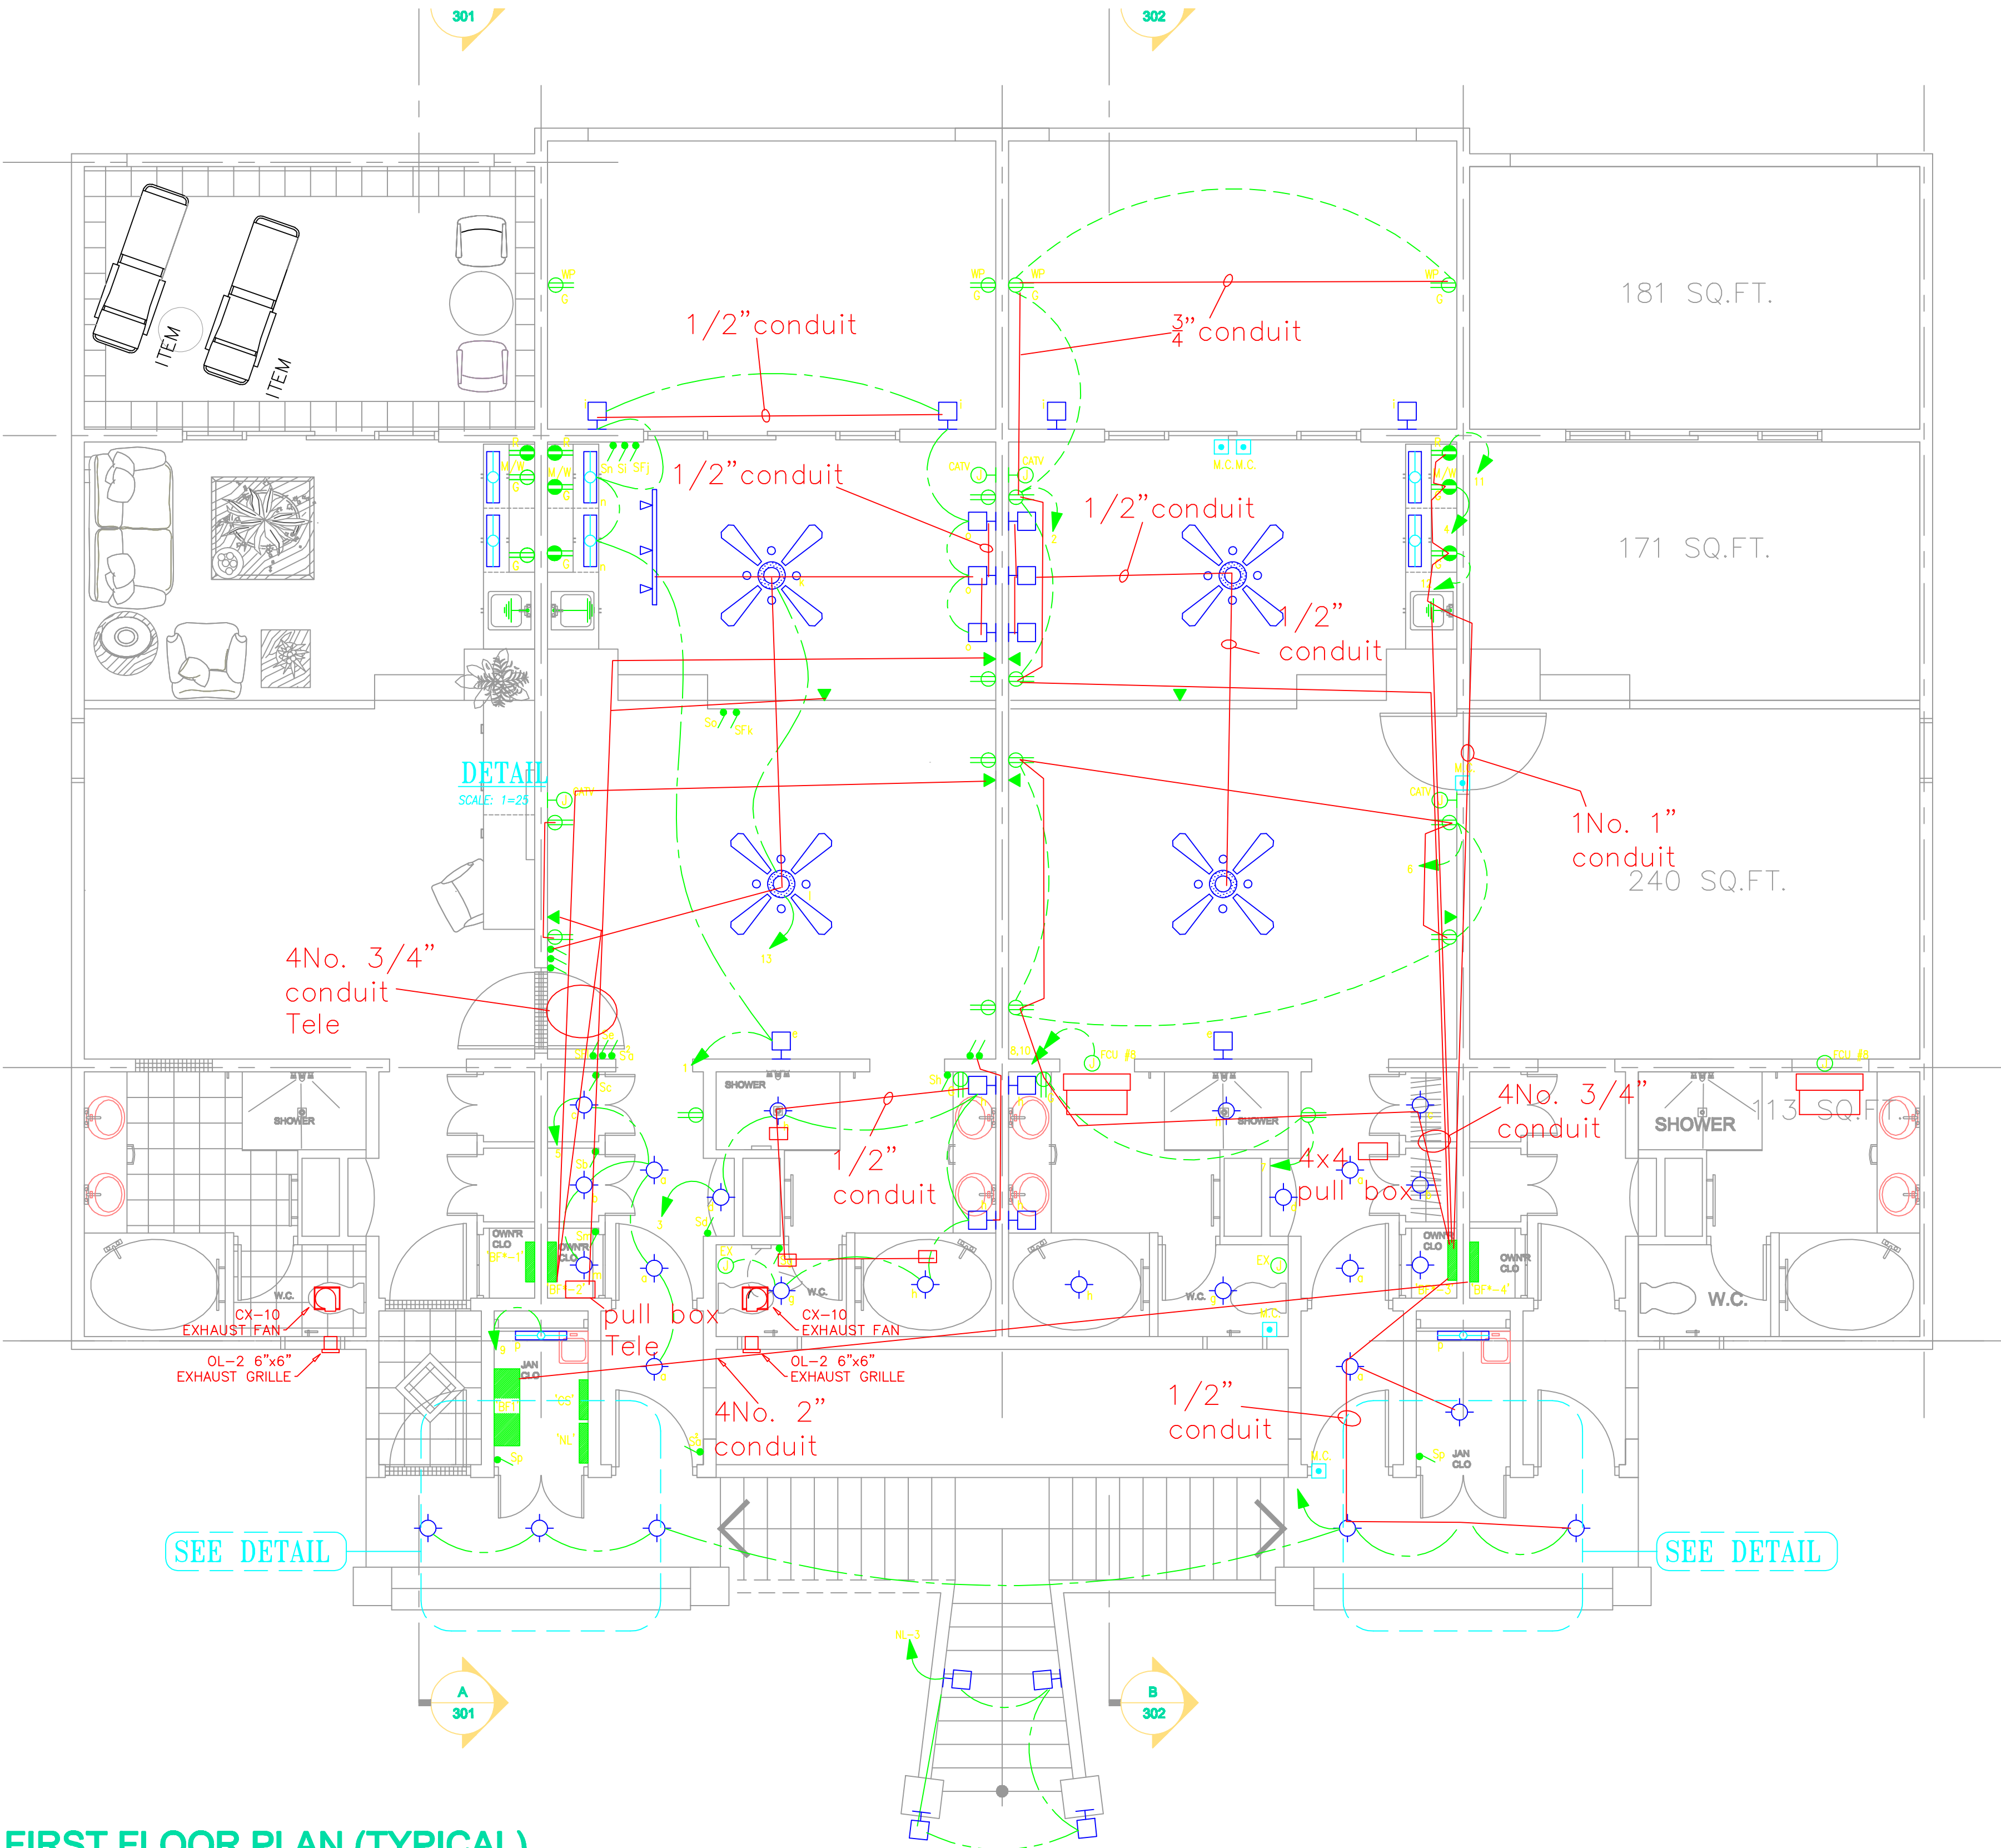


FIRST FLOOR PLAN (TYPICAL)

SCALE: 1/4" = 1'

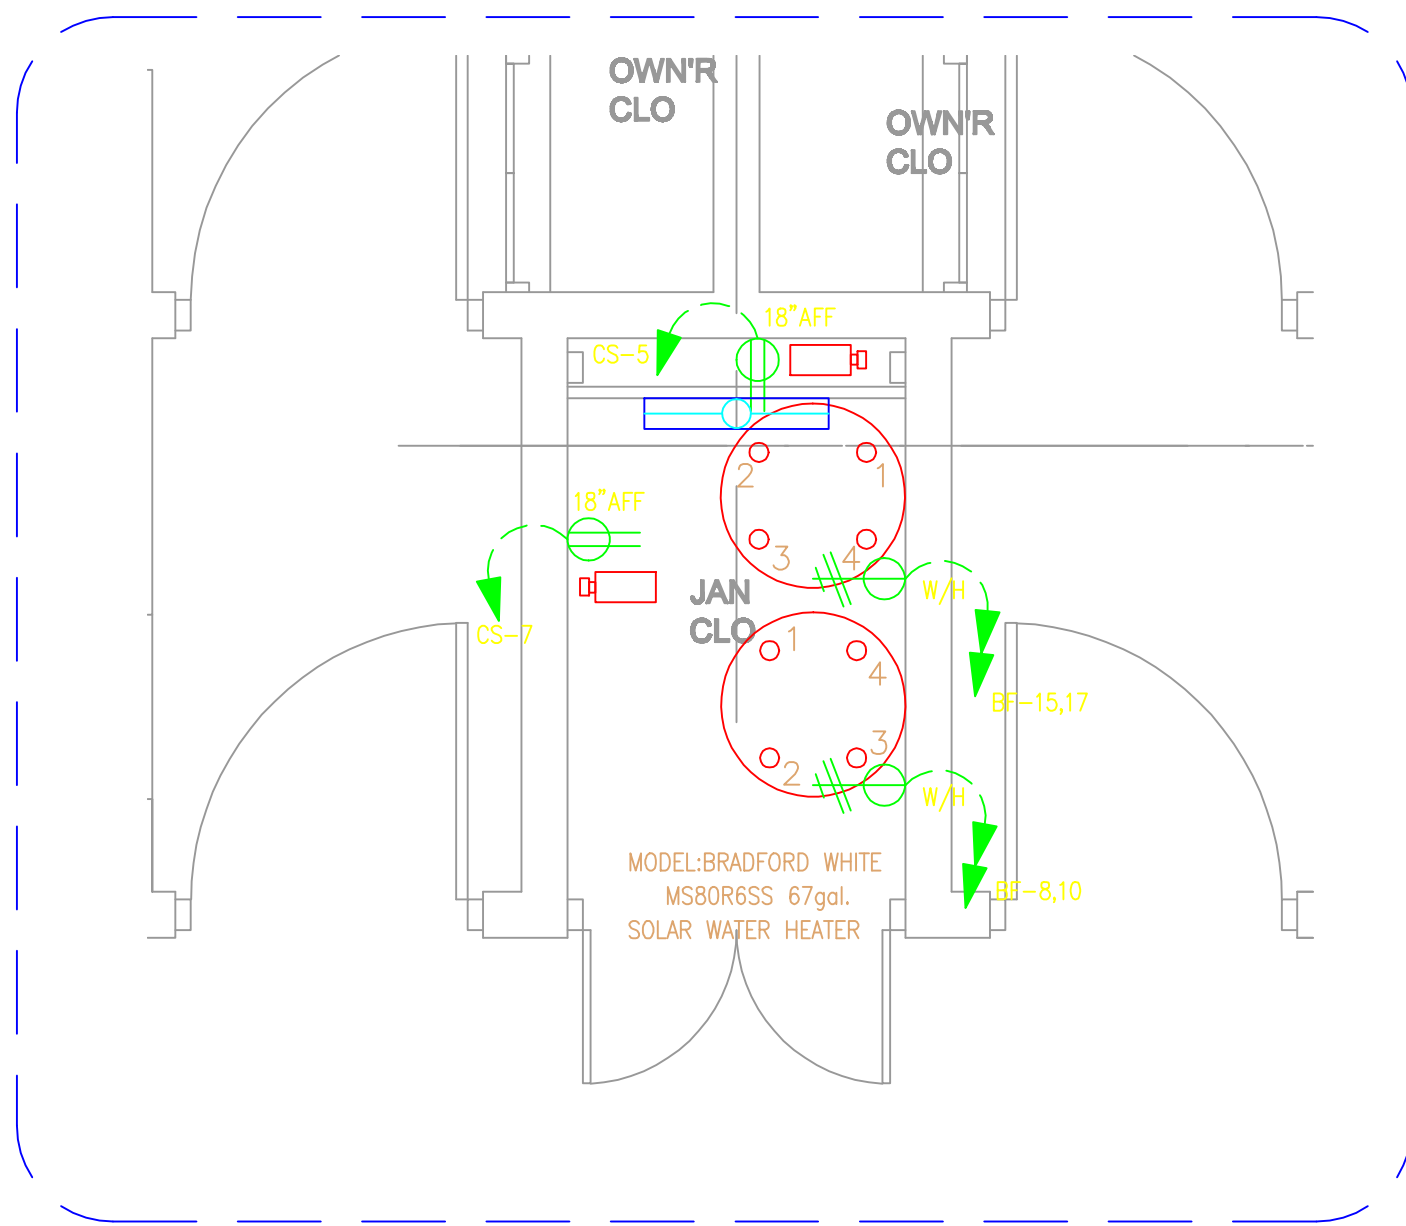

DETAIL
SCALE: 1/2" = 1'

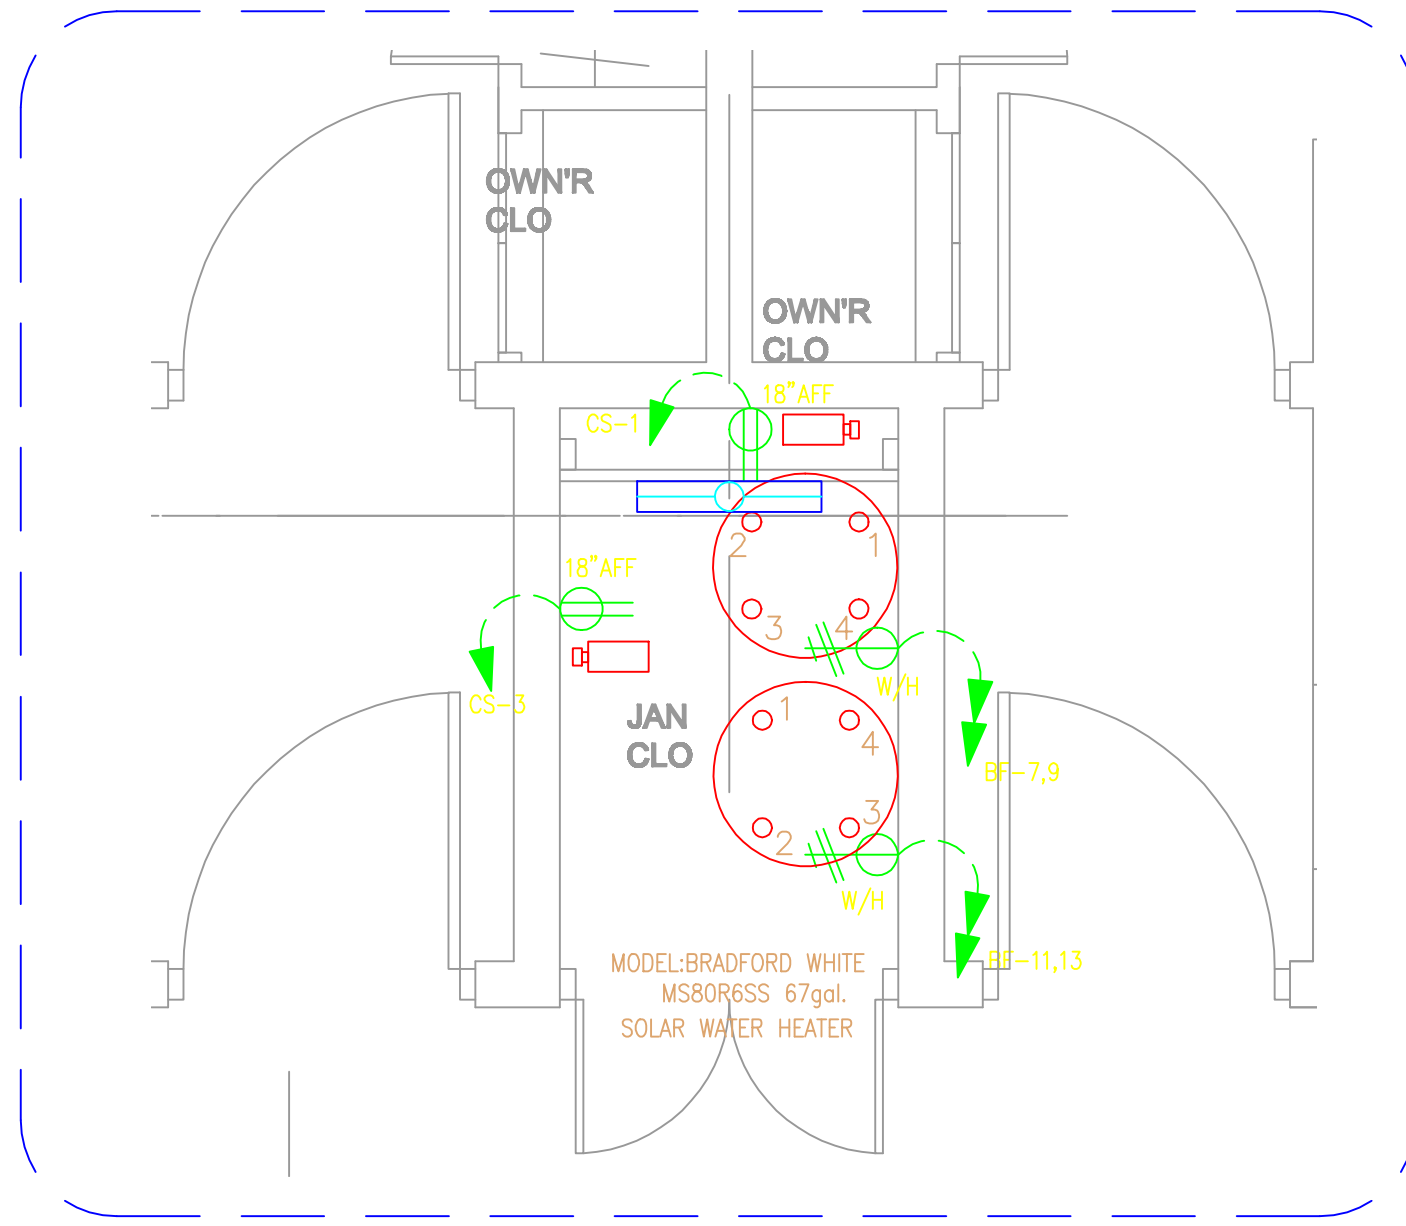

DETAIL
SCALE: 1/2" = 1'

LEGEND


- INCANDESCENT CEILING MOUNTED LIGHT FIXTURE - OWNER SUPPLIED
- WALL MOUNTED LIGHTING FIXTURE - OWNER SUPPLIED
- MAGNETIC CONTACT
- FAN AND LIGHT - OWNER SUPPLIED
- 4' 2 x 32w SURFACE MOUNTED FLUORESCENT - OWNER SUPPLIED
- SINGLE POLE LIGHT SWITCH 120V/277V 20A-EAGLE DECORATOR MODEL No. 6621V c/w IVORY COVER PLATE OR EQUAL
- TWO WAY LIGHT SWITCH 120V 20A - EAGLE DECORATOR MODEL No. 6623V c/w IVORY COVER PLATE OR EQUAL
- FAN OUTLET/SPEED CONTROLLER - OWNER SUPPLIED
- COOKER SWITCH - OWNER SUPPLIED
- GENERAL PURPOSE CONVENIENCE OUTLET- 15A 115V DUPLEX WITH 'U' GROUND NEMA 5-15R EAGLE BR15V OR EQUAL
- WEATHERPROOF OUTLET - EAGLE GF15V
- GROUND FAULT - EAGLE GF15V OR EQUAL
- SEPARATE CIRCUIT OUTLET - AS ABOVE
- MICROWAVE UNIT
- REFRIGERATOR
- SPECIAL PURPOSE SWITCHED OUTLET - 250V 3-POLE
- WASHER/DRYER - 125/250V 30A 4-POLE EAGLE 125B RECEPTACLE AND MK DP LOGIC 5105 WHI 240V 32A ILLUMINATED DRYER SWITCH
- COOKER - 125/250V 50A 4-POLE EAGLE 1257 RECEPTACLE AND MK DP LOGIC 5215 WHI 240V 45A ILLUMINATED COOKER SWITCH
- WALL MOUNTED JUNCTION BOX
- CABLE T.V. OUTLET - EAGLE 1172 OR EQUAL
- A/C THERMOSTAT STATION - 2" x 4" 4/B VERTICALLY MOUNTED
- TELEPHONE OUTLET - EAGLE TWO 3531 OR EQUAL
- ELECTRICAL PANEL
- CONDUIT RUN IN CEILING OR WALL
- CONDUIT RUN IN FLOOR

NOTES

- ALL ELECTRICAL WORK SHALL BE DONE ACCORDING TO LOCAL CODES AND ORDINANCES.
- ALL OUTLET LOCATIONS ARE MEASURED TO CENTER LINE OF BOX.
- THE HEIGHT OF ALL OUTLETS TO BE 16" AFF UNLESS OTHERWISE NOTED.
- SWITCH PLATES, OUTLET, COVERS TO BE WHITE UNLESS OTHERWISE NOTED. ALL OPEN BOXES TO HAVE BLANK PLATES.
- ELECTRICAL CONTRACTOR SHALL LABEL ALL BREAKER PANELS AND MARK UP A SET OF ARCHITECTURAL PLANS INDICATING CIRCUITS AS INSTALLED.
- PROVIDE OBM WITH A COPY OF THE APPROVED ELECTRICAL INSPECTION.
- ALL WIRING SHALL BE CONCEALED UNLESS OTHERWISE NOTED.
- CABLE SIZES:
LIGHTING.....1.5mm²
CONV./OLS.....2.5mm²
WASHER/DRYER..... 4.0mm²
COOKER.....10mm²
PUMP.....1.5mm²
SOLAR WATER HEATER..... 1.5mm²
A/C CONDENSING UNITS.....16mm²
FAN COIL UNITS.....1.5mm²

AS-BUILT DRAWING
Date! 22-01-10

REVISION	DATE	DESCRIPTION	BY	APP'D
1	11.04.08	GENERAL REVISION	A.S.	
2	19.03.08	GENERAL REVISION	A.S.	
3		DESCRIPTION		
OBM		OBM Limited Architecture Recent Design & Development Town Planning Interior Design	PO Box 908 St. John's Antigua www.obmltd.com E: obm@obmltd.com T: 268 462 1041 F: 268 462 2005	Antigua St. John's Antigua St. John's Antigua St. John's Antigua St. John's
		CABLE BAY PROPERTY DEVELOPMENT		
edc		EDC CONSULTANTS LTD 42, Lois Street, Woodbrook, P.O.S., Trinidad, W. Ind. (865)628-8604 Fax(865)622-7775		
FILE NAME:		cablebay-grd-lig-pow		
TRUC:		ELECTRICAL		
DWG. TITLE:		BEACH FRONT APTS-FIRST FLOOR LIGHTING/POWER LAYOUT		
DESIGNED:	EDC.C.L.	DRAWN:	A.S.H.A.H.	PROJECT NO.: 05-030
DATE:	20/01/06	SCALE:	1/4" = 1'	DWG. NO.: E-07
		APP'D:		REVISION: 2

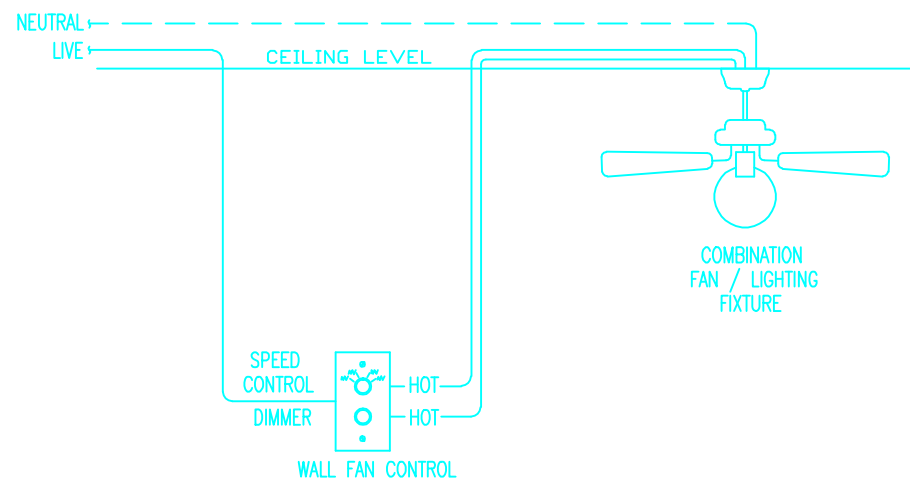

FAN CONTROL WIRING SCHEMATIC

(NOTE: CEILING FANS & SPEED CONTROL SWITCHES TO BE OWNER SUPPLIED)